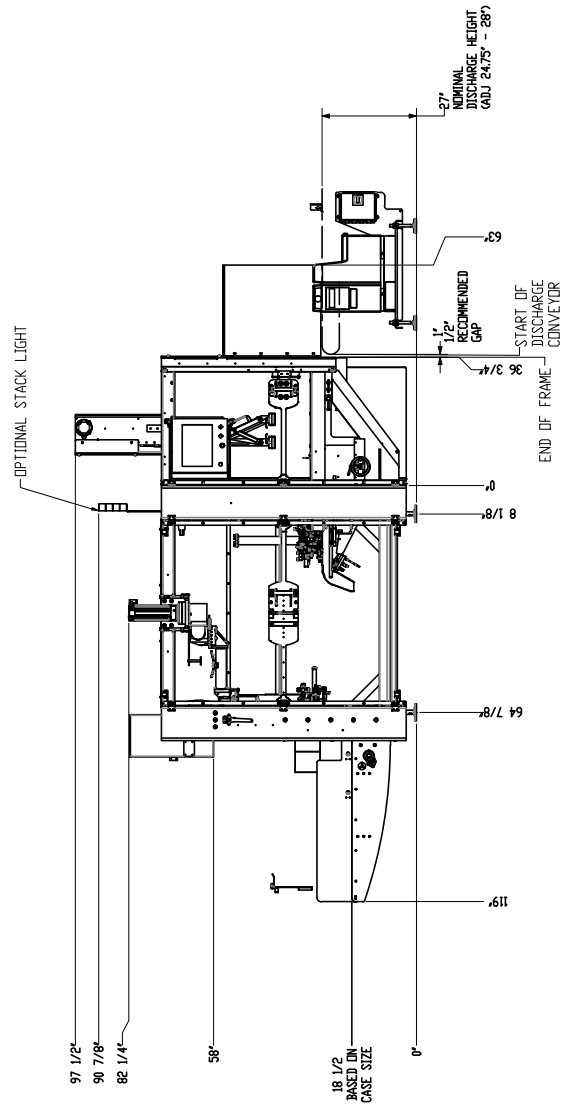
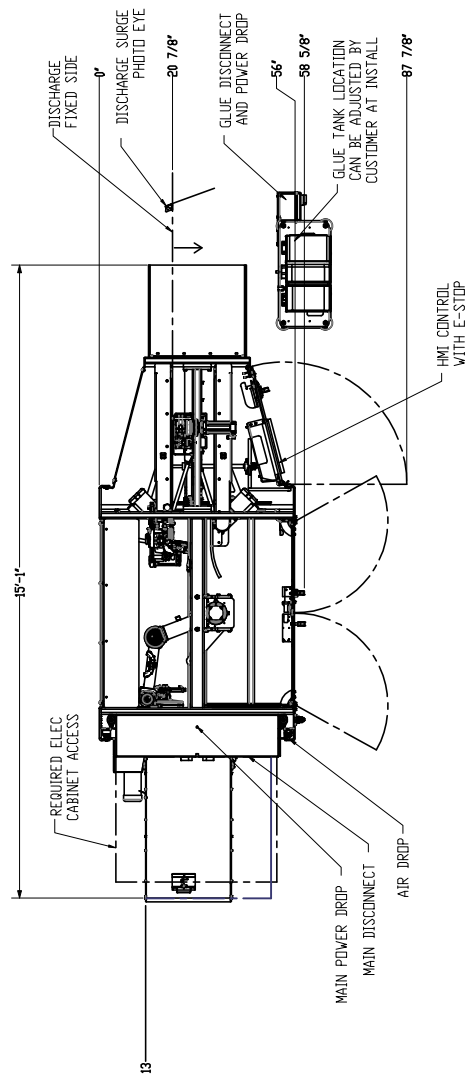


MACHINE SPECIFICATIONS	
MACHINE VOLTAGE	480V-3PH-60HZ
TEST AMP LOAD	14 AMPS @ 480V
MAIN DISCONNECT	30 AMP FUSED 15 AMP
TEST CLAMP AMP LOAD	5 AMPS @ 480V
RELIEF DISCONNECT	30 AMP FUSED 15 AMP
TEST AMP DISC	6.574 AMP 208V3

NOTE - PRELIMINARY FLOOR PLAN FOR ORIENTATION OF BASE PRICE MACHINE ONLY, DIMENSIONS ARE SUBJECT TO CHANGE ACCORDING TO DESIGN REQUIREMENTS AND OPTIONS PURCHASED

REV.	DATE	BY	DESCRIPTION	QUANTITY	UNIT	PRICE
ShurTape 1701 17th Street, Suite 202 14807-1702, TX 76039-1702 This drawing and the information contained is the sole property of Shurtape Technologies LLC It is not to be used, copied, retransmitted, or otherwise distributed without the prior written consent of Shurtape Technologies LLC AUTOMATIC CASE ERECTOR RIGHT HAND, GLUE, 4FT MAG DRAWN BY: J-LK CHECKED BY: T-DALE DATE: 11/11/2022 SCALE: 1/8" = 1' SHEET: 1 OF 1						